


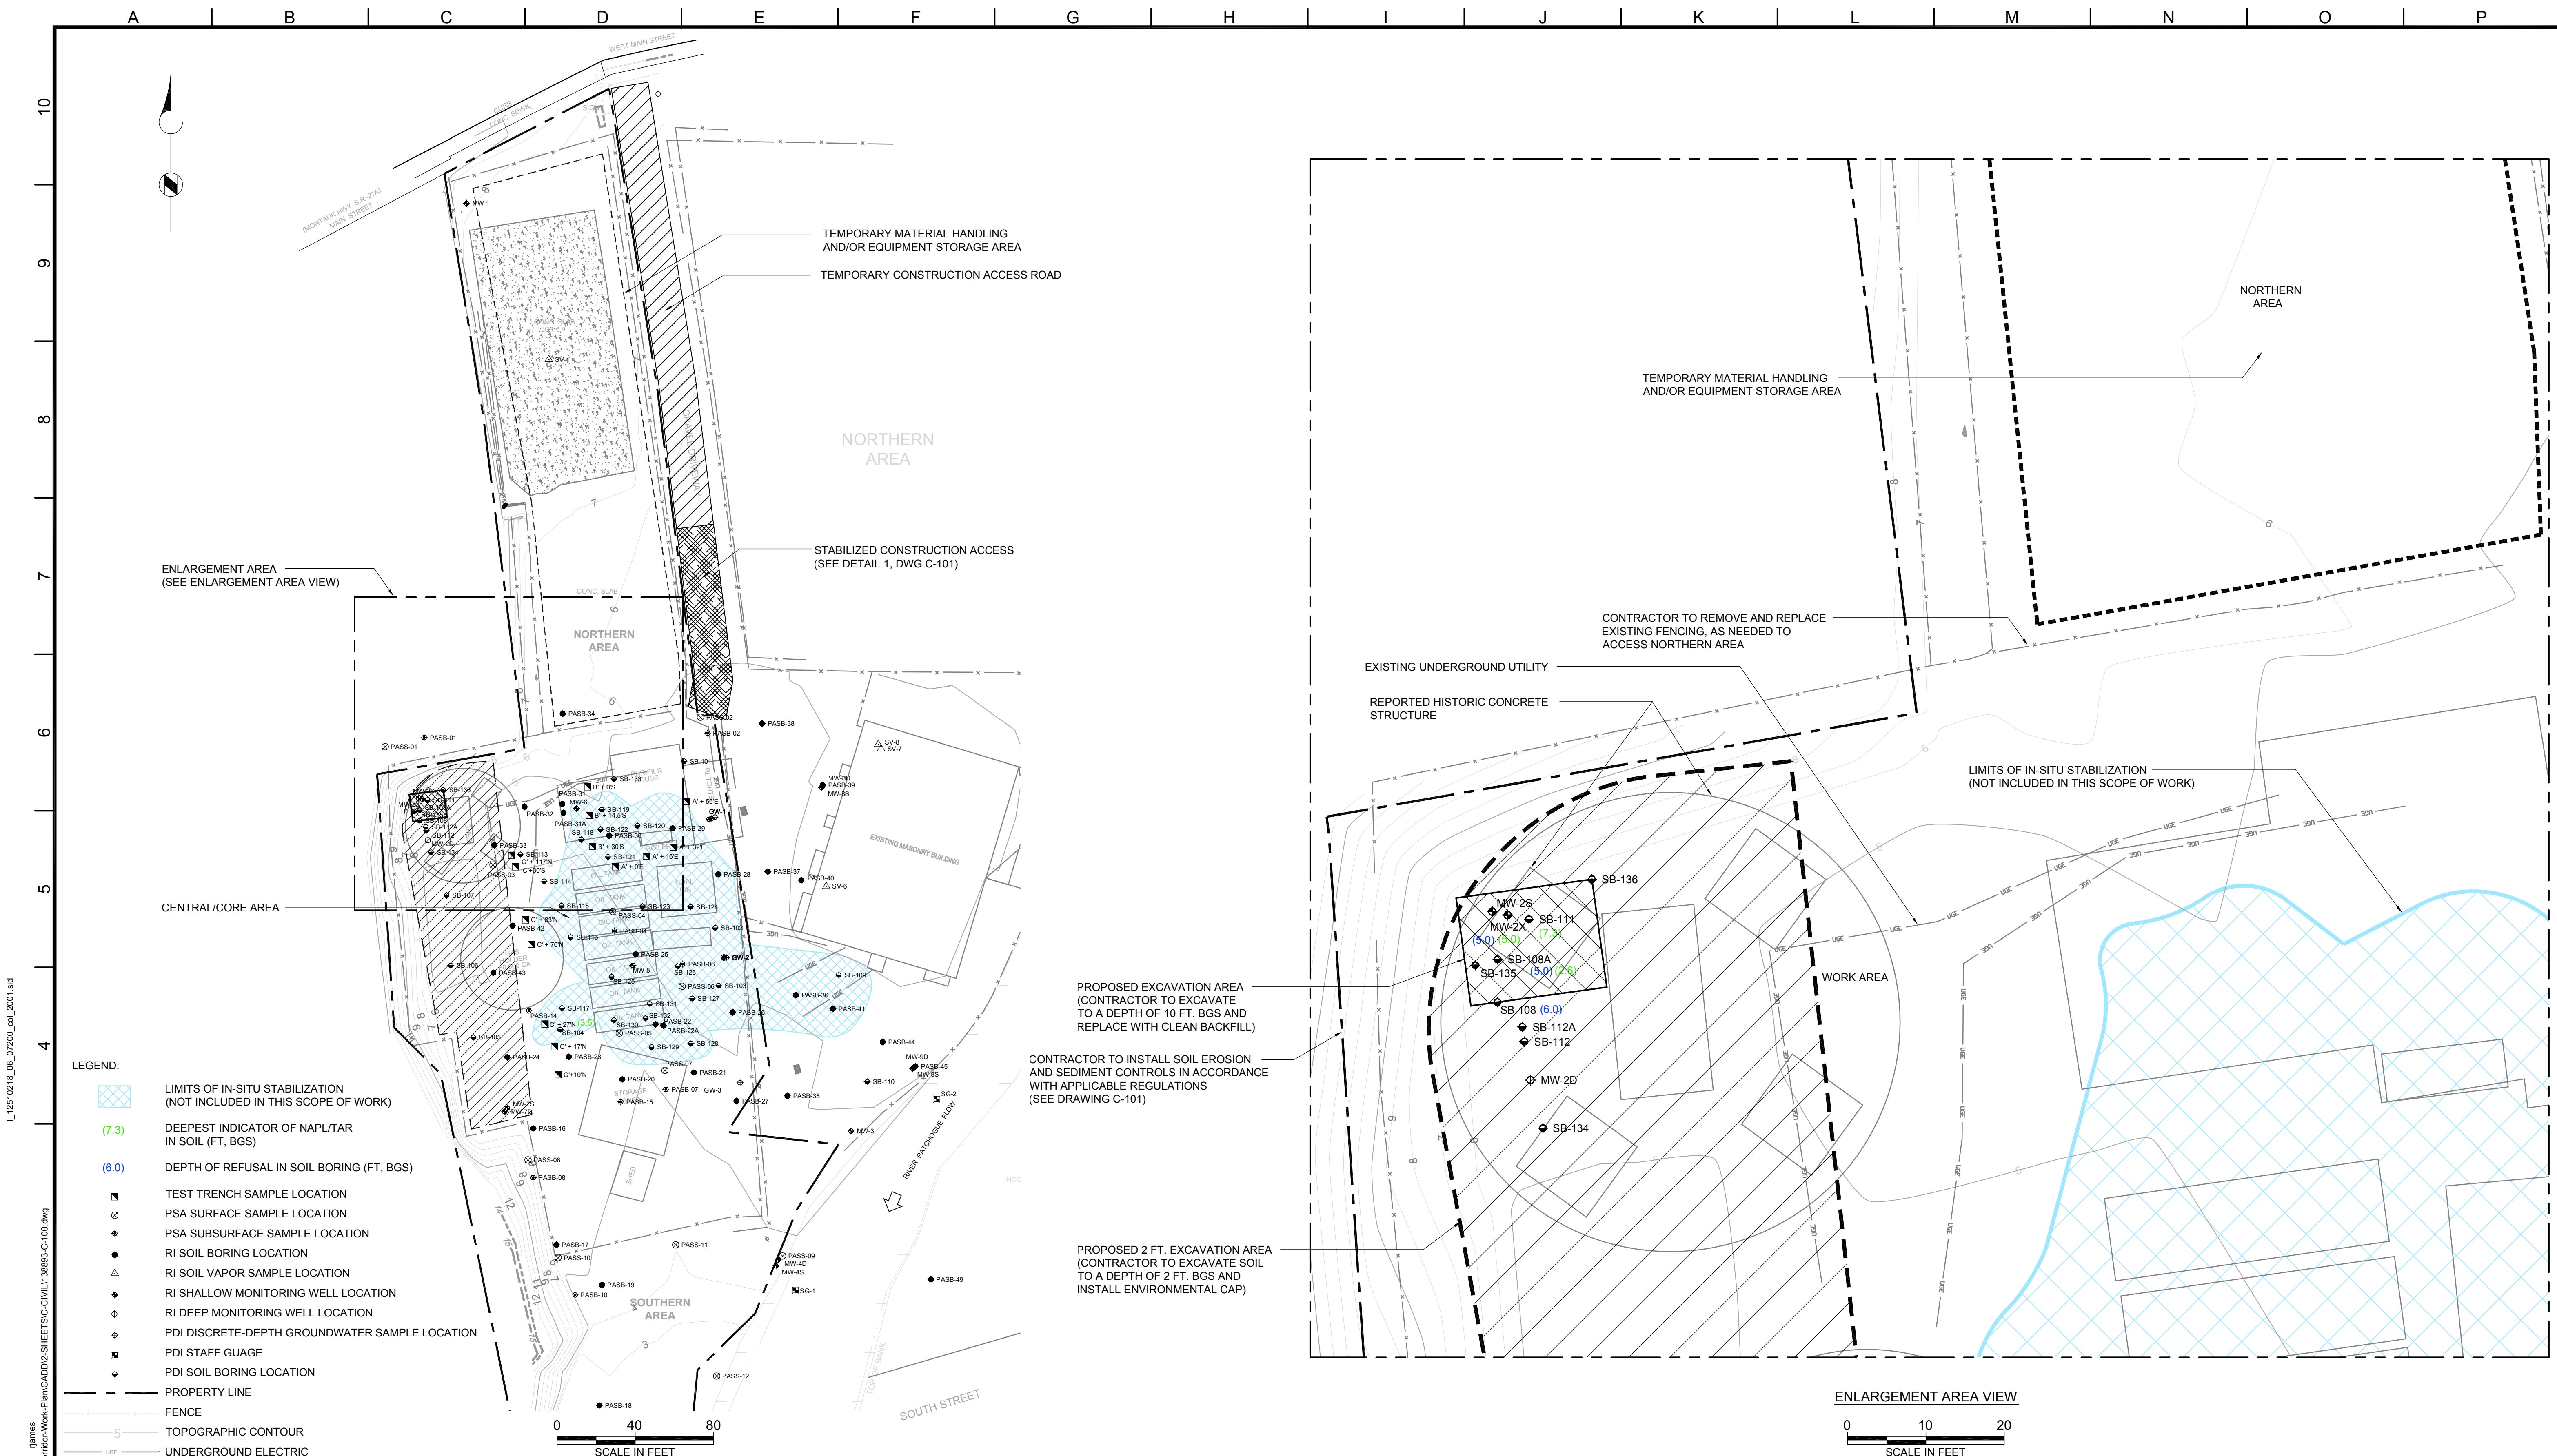

L:\2510218_06_07200_col_2001.sxd
P:\National_Grid\Patchogue\138893-Utility-Corridor-Work-Plan\CADD\2-SHEET\SC-CIVIL\138893-C-100.dwg
1/10/2012 4:43pm
P:\National_Grid\Patchogue\138893-Utility-Corridor-Work-Plan\CADD\2-SHEET\SC-CIVIL\138893-C-100.dwg

Brown and Caldwell
ASSOCIATES
ALLENDALE, NEW JERSEY
N.J. C.A. 24GA28043100

SUBMITTED: KEITH BOGATCH DATE: 11-7-2011
PROJECT MANAGER
APPROVED: JEFF CAPUTI DATE: 11-7-2011
BROWN AND CALDWELL

LINE IS 2 INCHES
AT FULL SIZE
(IF NOT 2" - SCALE ACCORDINGLY)
DESIGNED: PP
DRAWN: RJ
CHECKED: KB
CHECKED:
APPROVED: JC

EXTERNAL REFERENCE FILES
138893-G-001.dwg
Basemap.dwg
Sample-Location.dwg
Topo.dwg

JEFFREY R. CAPUTI
PROFESSIONAL ENGINEER
N.Y. LICENSE NO. 048454E

DATE

REVISIONS					
ZONE	REV.	DESCRIPTION	BY	DATE	APP.

NATIONAL GRID
PATCHOGUE FORMER MGP SITE
VILLAGE OF PATCHOGUE, NEW YORK

UTILITY CORRIDOR WORK PLAN

SITE PLAN

FILENAME
BC PROJECT NUMBER
138893.420
CLIENT PROJECT NUMBER
DRAWING NUMBER
C-100
SHEET NUMBER
1 OF 3